


**FLOOR PLAN 3 BEDROOM 1122 SF**  
 UNLESS NOTED OTHERWISE ALL WALLS 2x4 @ 16" OC INTERIOR 2x6 @ 16" EXTERIOR. 1/4"=1'-0"  
 A6009-1122SF-3BR-LA

**DOOR & WINDOW SCHEDULE**

DOOR/WINDOW NO	QUANT	SIZE	DOOR			WINDOW			FRAME		DETAILS			LABEL	REMARKS	DOOR TYPE SKETCH
			TYPE	MAT	FINISH	GLAZE	MAT	FINISH	HEAD	JAMB	SILL					
1	1	16'-0"x8'-0"	F	INSUL STL.	S.G. ENAM.	N/A	MDF	S.G. ENAM.	A/4 11/5	11/5	MFR STD.	N/A	N/A	* CEDAR EXTERIOR SURROUND & TRIM - NO INT. TRIM OWNER/CONTRACTOR OPTION - SUBSTITUTE 7'-0" HIGH DR.		
2	1	6'-0"x6'-8"	E	VINYL	S.G. ENAM.	TEMPERED INSULATED	MDF	S.G. ENAM.	5/5 SIM.	5/5 SIM.	MFR STD.	N/A	N/A	* MFR STANDARD W/ MDF INT CASING.		
3	1	3'-0"x6'-8"x1.3/4"	D	INSUL STL.	S.G. ENAM.	N/A	MDF	S.G. ENAM.	1/5 SIM	1/5 SIM	MFR STD.	N/A	N/A	* MFR STANDARD / MDF INT CASING 9" SIDELITE W/ DECORATIVE PANEL.		
4	1	3'-0"x6'-8"x1.3/4"	C			TEMPERED INSULATED					MFR STD.	N/A	N/A	* MFR STANDARD / MDF INT CASING		
5	1	2'-8"x6'-8"x1.3/4"	D								MFR STD.	N/A	20 MIN	* MFR STANDARD / MDF CASING		
6 THRU 8	2	4'-0"x6'-8"x1.3/8"	B	PB CORE THERMAFOIL			MDF		7/5	7/5	7/5	N/A	N/A	* MDF CASING		
9	1	5'-0"x6'-8"x1.3/8"	B									N/A	N/A	* MDF CASING		
9 THRU 13	5	2'-6"x6'-8"x1.3/8"	D						1/5	1/5	N/A	N/A	N/A	* MDF CASING		
14	1	2'-6"x6'-8"x1.3/8"	D									N/A	N/A	* MDF CASING		
15	1	4'-0"x6'-8" GYP CASED OPENING						N.A				N/A	N/A			
A	SEE PLAN	4'-0"x4'-6"	1	VINYL	FACTORY	INSUL	HEMLOCK	S.G. ENAM.	6/5	6/5	6/5	N/A	N/A	GYP SURROUND W/ 3/4" MDF SILL BEDROOM WINDOWS SHALL COMPLY W/ ORSC R310 PROVIDE 5'-0" HIGH WINDOW IF REQ'D FOR COMPLIANCE		
B	SEE PLAN	3'-0"x4'-6"	1						6/5	6/5	6/5	N/A	N/A	GYP SURROUND W/ 3/4" MDF SILL		
C	SEE PLAN	3'-0"x3'-6"	1						6/5	6/5	6/5	N/A	N/A	3/4" MDF SURROUND & CASING W/ 3/4" MDF SILL		
D	SEE PLAN	5'-0"x4'-6"	2						6/5	6/5	6/5	N/A	N/A	GYP SURROUND W/ 3/4" MDF SILL		
E	NOT USED															
F	NOT USED															

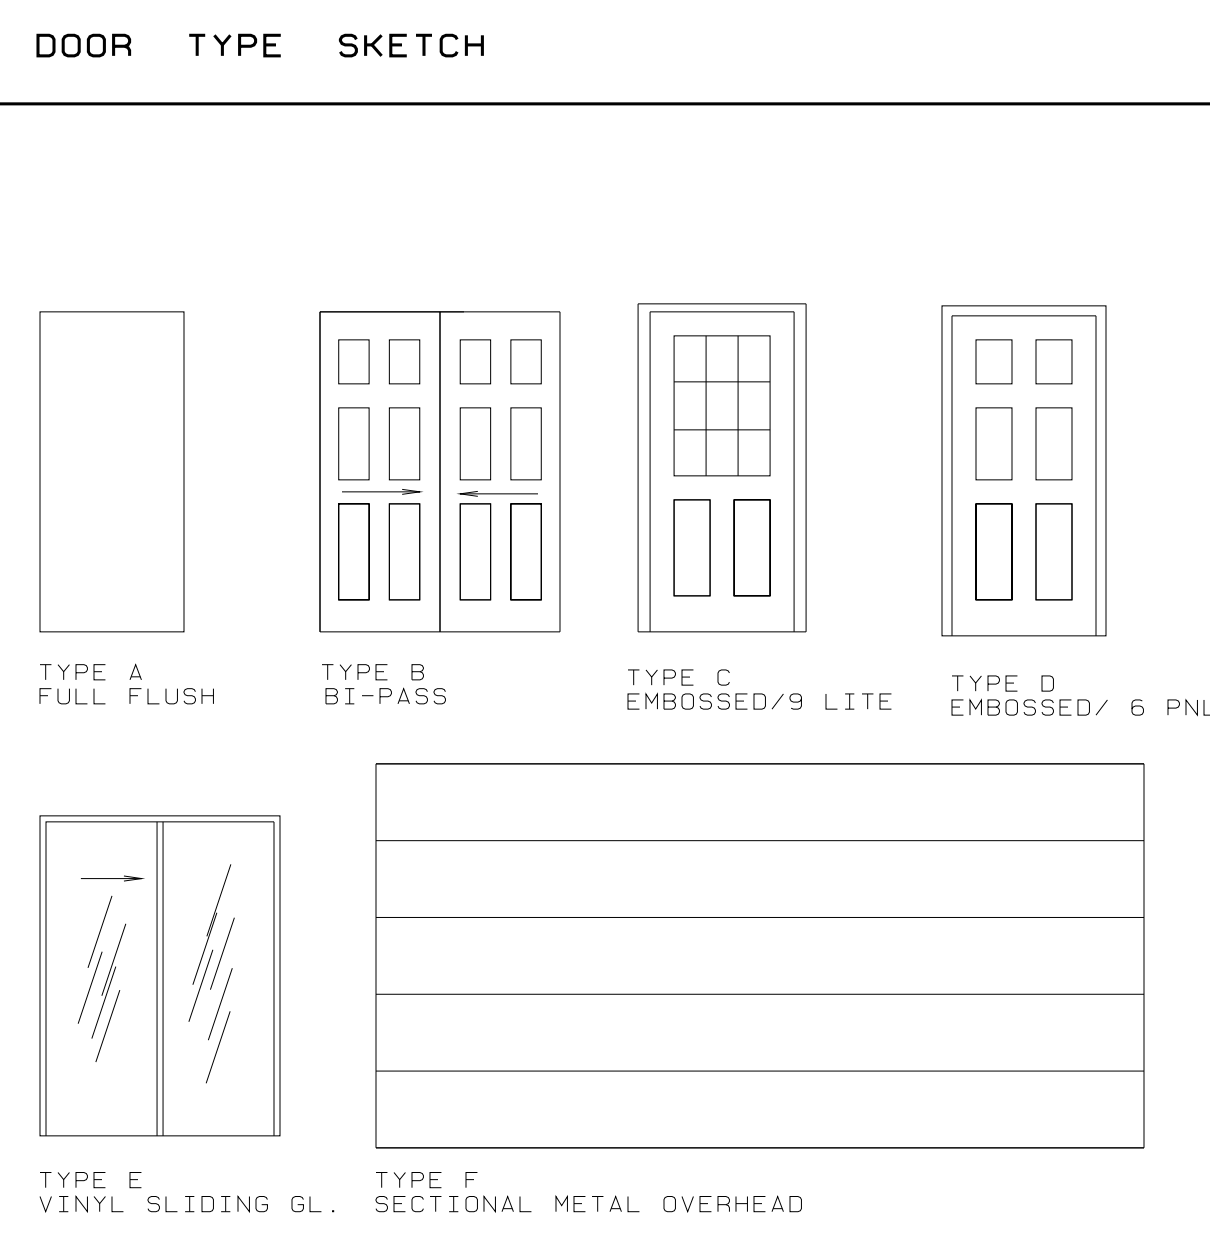

GENERAL NOTES:  
 1. VERIFY HARDWARE REQUIREMENTS W/ OWNER PRIOR TO ORDERING LOCKS AND OTHER HARDWARE SUBJECT TO OWNER'S APPROVAL  
 2. ALL INTERIOR CASINGS "COLONIAL" PROFILE UNLESS NOTED OTHERWISE.

**PLUMBING FIXTURE SCHEDULE**


MARK	MFR.	DESCRIPTION ** ALL FIXTURES SELECTED BY OWNER/CONTRACTOR SUBJECT TO REQUIREMENTS NOTED IN DESCRIPTION
T/S	**	60" ROUGH-IN FIBERGLASS TUB/SHOWER W/ TEMPERATURE BALANCING CONTROLS, FLOW RESTRICTOR PER CODE WASTE & OVERFLOW. SCREWDRIIVER STOPS.
SHR	**	48"x36" ROUGH-IN FIBERGLASS SHOWER W/ TEMPERATURE BALANCING CONTROLS, FLOW RESTRICTOR PER CODE. SCREWDRIIVER STOPS.
WC	**	WATER CLOSET W/ SEAT ANGLE STOPS RISERS & FLANGES
L	**	COUNTERTOP TYPE LAVATORY - FLOW RESTRICTOR PER CODE ANGLE STOPS
S	**	ST. STEEL, 33"x22" KITCHEN SINK
LT	**	WALL HUNG, FIBERGLASS LAUNDRY TRAY, VACUUM BREAKER TYPE FAUCET.
W/H	**	52 GALLON ELECTRIC WATER HEATER 240 V 4500 WATT.
HB	**	3/4" AUTOMATIC DRAINING FREEZELESS WALL HYDRANT; LENGTH AS REQUIRED BY CONDITIONS OF INSTALLATION.
WSHR	GUY-GREY	GUY GREY B-200 BOTTOM SUPPLY RECESSED WASHER CONNECTION 2" DRAIN; (9"x10.3/4") 31" MOUNTING HEIGHT.

IN THE EVENT OF DISCREPANCIES BETWEEN THE WRITTEN DESCRIPTIONS AND MODEL NUMBER, THE WRITTEN DESCRIPTION SHALL TAKE PRECEDENCE.  
 INCIDENTAL ITEMS REQUIRED BY CODE FOR INSTALLATION OF SCHEDULED FIXTURES SHALL BE PROVIDED WHETHER OR NOT SPECIFICALLY NOTED. (EG. HOSE BIB, SEISMIC RESTRAINTS, VACUUM BREAKERS, HWH DRAIN PAN & DRAIN LINE, HYDRANT KEYS, ETC.)  
 ALL PIPING IN UNHEATED SPACES TO HAVE 1" INSULATION


**ELECTRICAL FIXTURE SCHEDULE**

MARK	MFR.	DESCRIPTION ** ALL FIXTURES SELECTED BY OWNER/CONTRACTOR SUBJECT TO REQUIREMENTS NOTED IN DESCRIPTION
A	**	THERMAL CUT-OUT; DAMP LOCATION RATING. 100W A-19 LAMP.
B	**	LIGHT-EXHAUST; 70CFM EXHAUST, 1-100W INC. PROVIDE 4" DUCT TO WALL OR ROOF CAP. SWITCH SEPARATELY - NUTONE DT100LMM OR APPROVED - HUMIDITY SENSING W/ TIMER
C	**	WALL BRACKET - *84" DAMP LOCATION RATING. 100W A-19 LAMP.
D	**	36" OR 48" UNDER CABINET FLOURESCENT
E	**	36" VALANCE/VANITY LIGHT
F	**	OTHER CEILING MOUNTED FIXTURES TO BE SELECTED BY OWNER/CONTRACTOR
L	**	30" WIDE; 200 CFM DUCTED RANGE HOOD W/ 75W LAMP PROVIDE 3.1/4"x10" DUCT TO WALL & WALL CAP PER CODE.
N	**	DOORBELL BUTTON *48"
DB	**	DOORBELL CHIME - MOUNT *84" LOCATE - 16V 10W TRANSFORMER IN CLOSET & CONNECT W/ ANY LEGAL CIRCUIT.
SD	**	CODE APPROVED SMOKE DETECTOR.

**ELECTRICAL SYMBOL KEY**

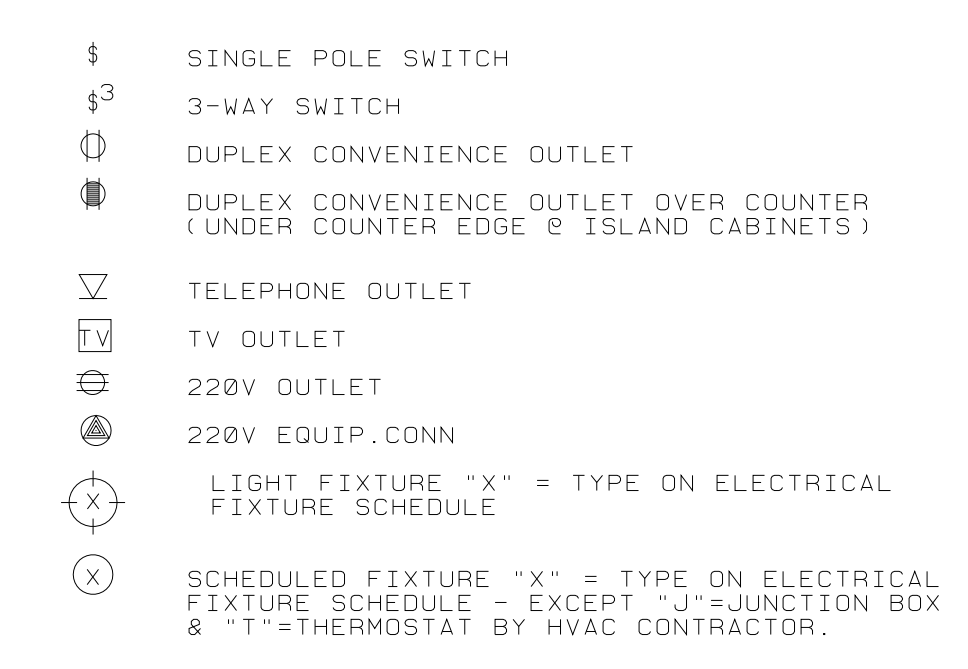


**WINDOW TYPE SKETCH**

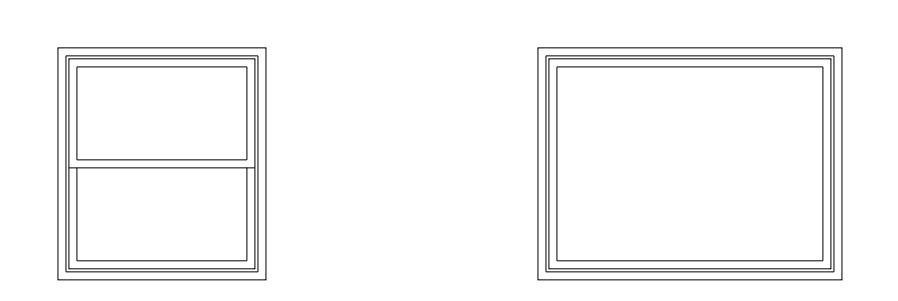

TYPE 1 VINYL - SINGLE HUNG 2-ED. SECTIONS  
 TYPE 2 VINYL - PICTURE WINDOW FIXED

**DALLAS W. HORN, ARCHITECT**  
 MEMBER - AMERICAN INSTITUTE OF ARCHITECTS  
 840 SE ROSE - ROSEBURG, OR 97470  
 PHONE: (541) 672-5658  
 dwh@rio.com

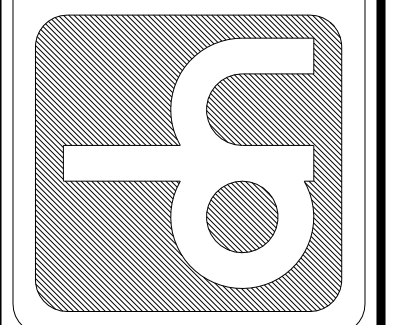

REGISTERED ARCHITECT  
 DALLAS HORN  
 DOUGLAS COUNTY, OREGON  
 NO. 0010  
 STATE OF OREGON

SELF HELP HOUSING - 3 BEDROOM DWELLING LA-1  
 DOUGLAS COUNTY, OREGON  
 OWNER-DEVELOPER - UMPQUA COMMUNITY DEVELOPMENT CORP.

FLOOR PLAN

PROJECT NO. A9003  
 L#02  
 DATE 1/21/09  
 REVISIONS  
 DRAWING SET NO.  
**SHEET NO**  
 OF 8